


May 28, 2025 -- 3:51pm
H:\Projects\2024\2024079 UMaine Blueberry Hill Friezer Packaging Facility Jonesboro\Irrigation RFP\2024079 - SITE_V5 5-28-25.dwg jonah

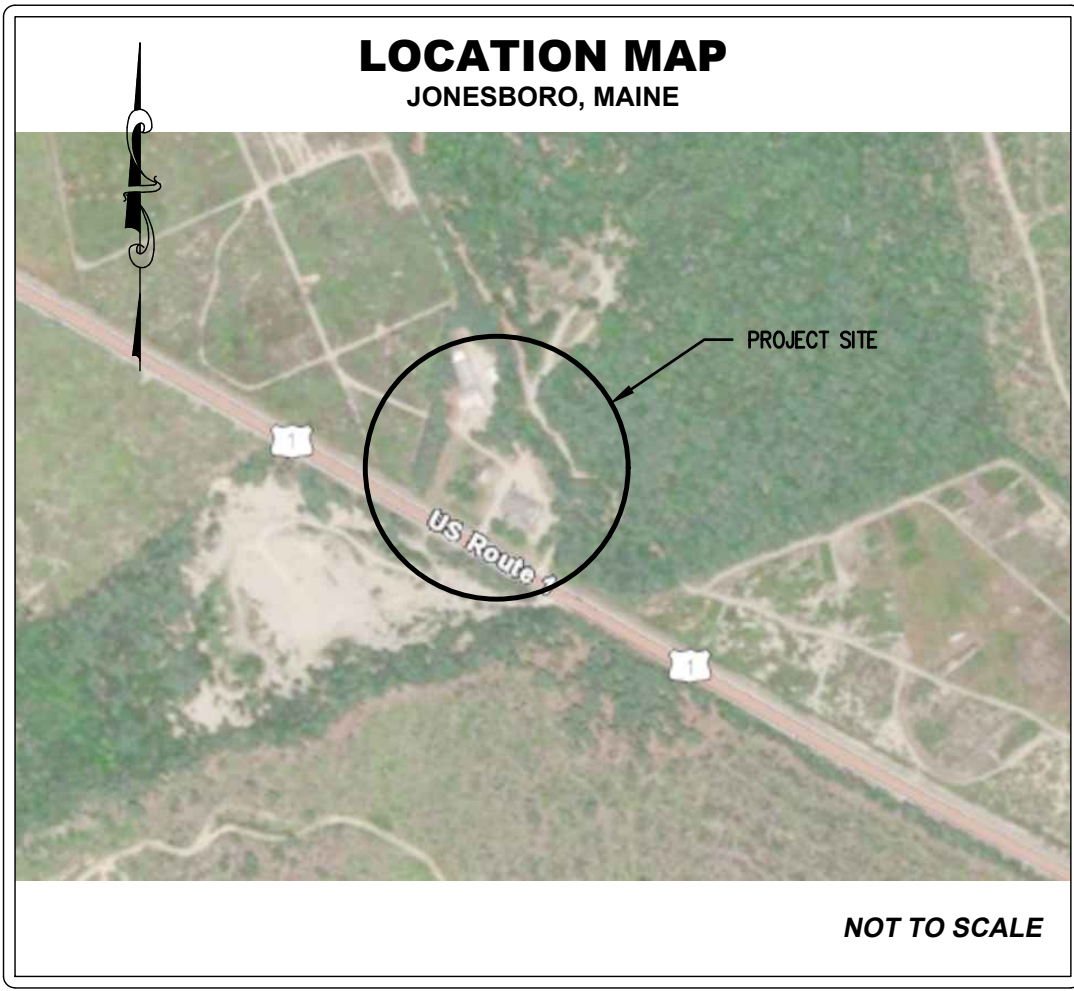


GENERAL NOTES:

1. PLAN BASED ON A SURVEY SUBMITTED BY PLUSGA & DAY, DATED: 01/27/2025.
2. CONTRACTOR SHALL CONTACT DIGSAFE PRIOR TO ANY EXCAVATION WORK.
3. CONSTRUCTION ACTIVITIES OCCURRING AFTER NOVEMBER 15TH SHALL INCORPORATE A WINTER CONSTRUCTION PLAN WHICH SHALL BE APPROVED BY THE TOWN.
4. THE CONTRACTOR SHALL TAKE MEASURES TO PREVENT SEDIMENT AND OTHER POLLUTANTS FROM ENTERING EXISTING DRAINAGE WAYS AND OTHER STORM WATER CONVEYANCES LOCATED ON THE SITE. CONTRACTOR MUST ADHERE TO BEST MANAGEMENT OF PRACTICES.
5. ELECTRICAL WORK MUST BE COORDINATED WITH UNIVERSITY OF MAINE, AND UTILITY.
6. CONTRACTOR IS RESPONSIBLE FOR VERIFYING THE EXACT LOCATION OF EXISTING UTILITIES WITH UMAINE
7. EROSION CONTROL MEASURES SHALL BE INSTALLED PRIOR TO BEGINNING OF CONSTRUCTION.


CARPENTER ASSOCIATES
CONSULTING ENGINEERS
687 STILLWATER AVENUE • OLD TOWN • MAINE 04468

REVISIONS		DESCRIPTION	
NO.	DATE	BY	

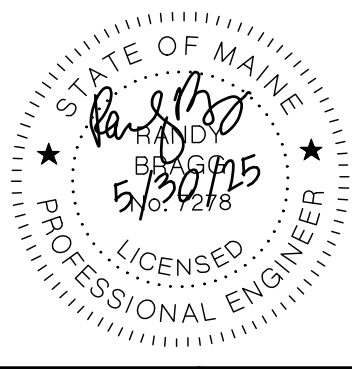


UNIVERSITY OF MAINE
BLUEBERRY HILL IRRIGATION
JONESBORO, MAINE

IRRIGATION WELL SITE PLAN

Drawn: JE
Checked: RB
Scale: 1" = 100'
Date: 05-30-2025
Project No: 2024079
Sheet Number:


C1

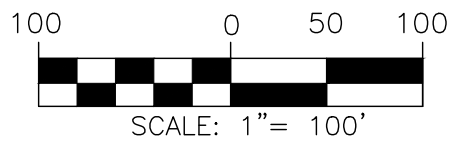

FOR BID
05-30-2025

WELL DESIGN NOTES:

- SKETCH BASED ON WELL DESIGN FROM J. THEODORE MORINE & OWEN MURRAY OF DENIS L. MAHER, DATED MARCH 20, 2025.
- SEE SPECIFICATION SECTION 33 11 33 FOR WELL SEALING AND GROUTING REQUIREMENTS.

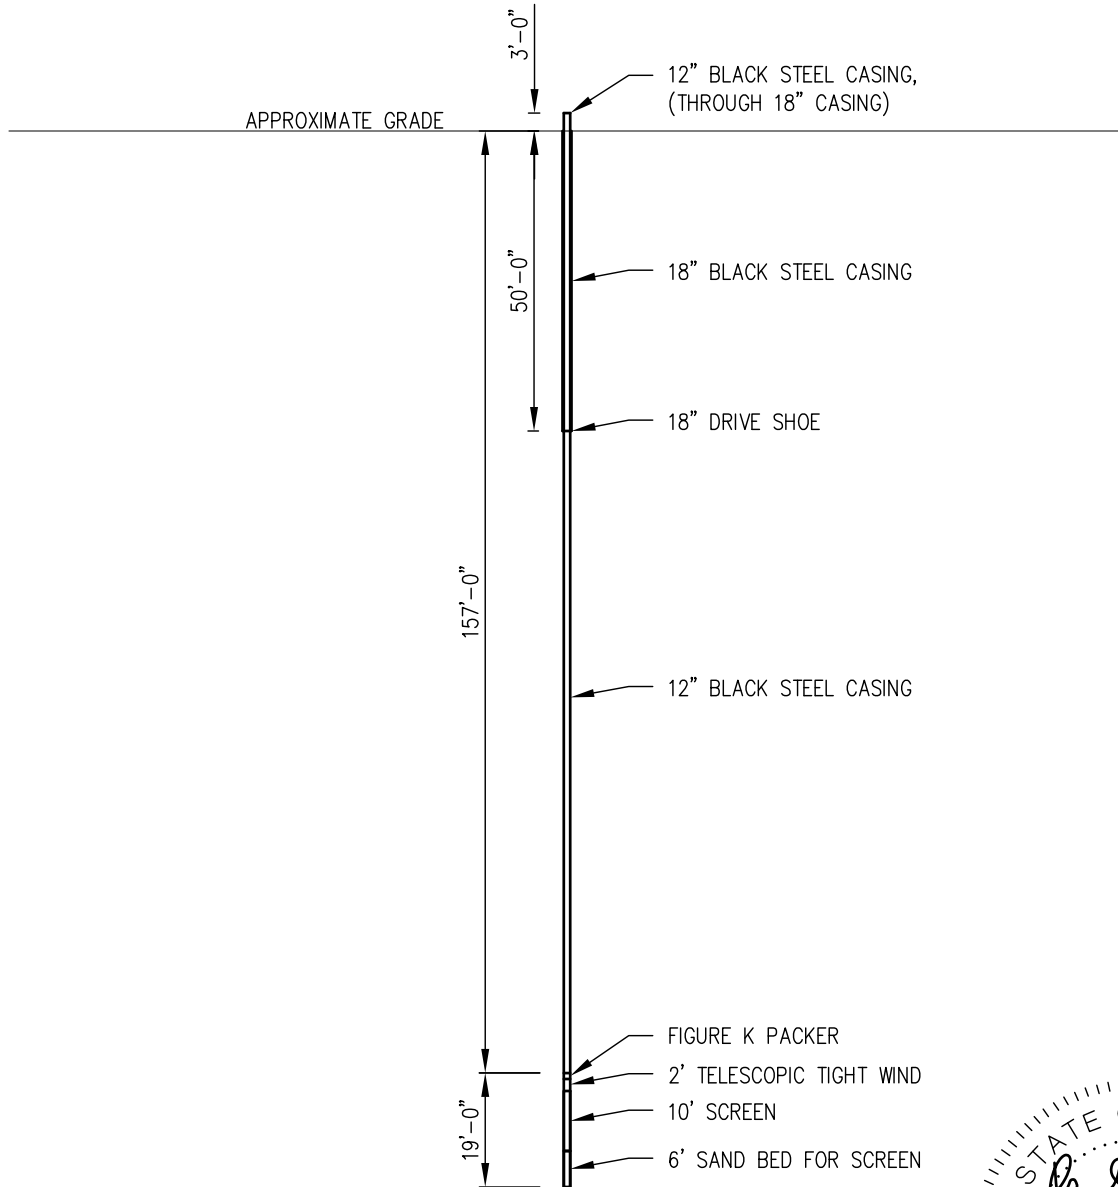

IRRIGATION WELL
SCALE: 1/32 = 1'-0"



FOR BID
05-30-2025



Drawn: JE
Checked: RB
Scale: AS NOTED

Date: 05-30-2025
Project No: 2024079

UNIVERSITY OF MAINE
BLUEBERRY HILL IRRIGATION
JONESBORO, MAINE

CARPENTER ASSOCIATES
CONSULTING ENGINEERS
OLD TOWN MAINE 04468

IRRIGATION WELL

C2