




GENERAL NOTES

- SEE SHEET A80-1 FOR INTERIOR PARTITION TYPES AND EXTERIOR WALL ASSEMBLY TYPES
- SEE SHEET A80-1 FOR CORNER GUARD DETAILS
- SEE SHEET A80-1 FOR DOOR SCHEDULE AND DETAILS

RFP-2026-119 UM Food Innovation Lab Attachment B
See Attachment A Cost Sheet for Pricing Submission

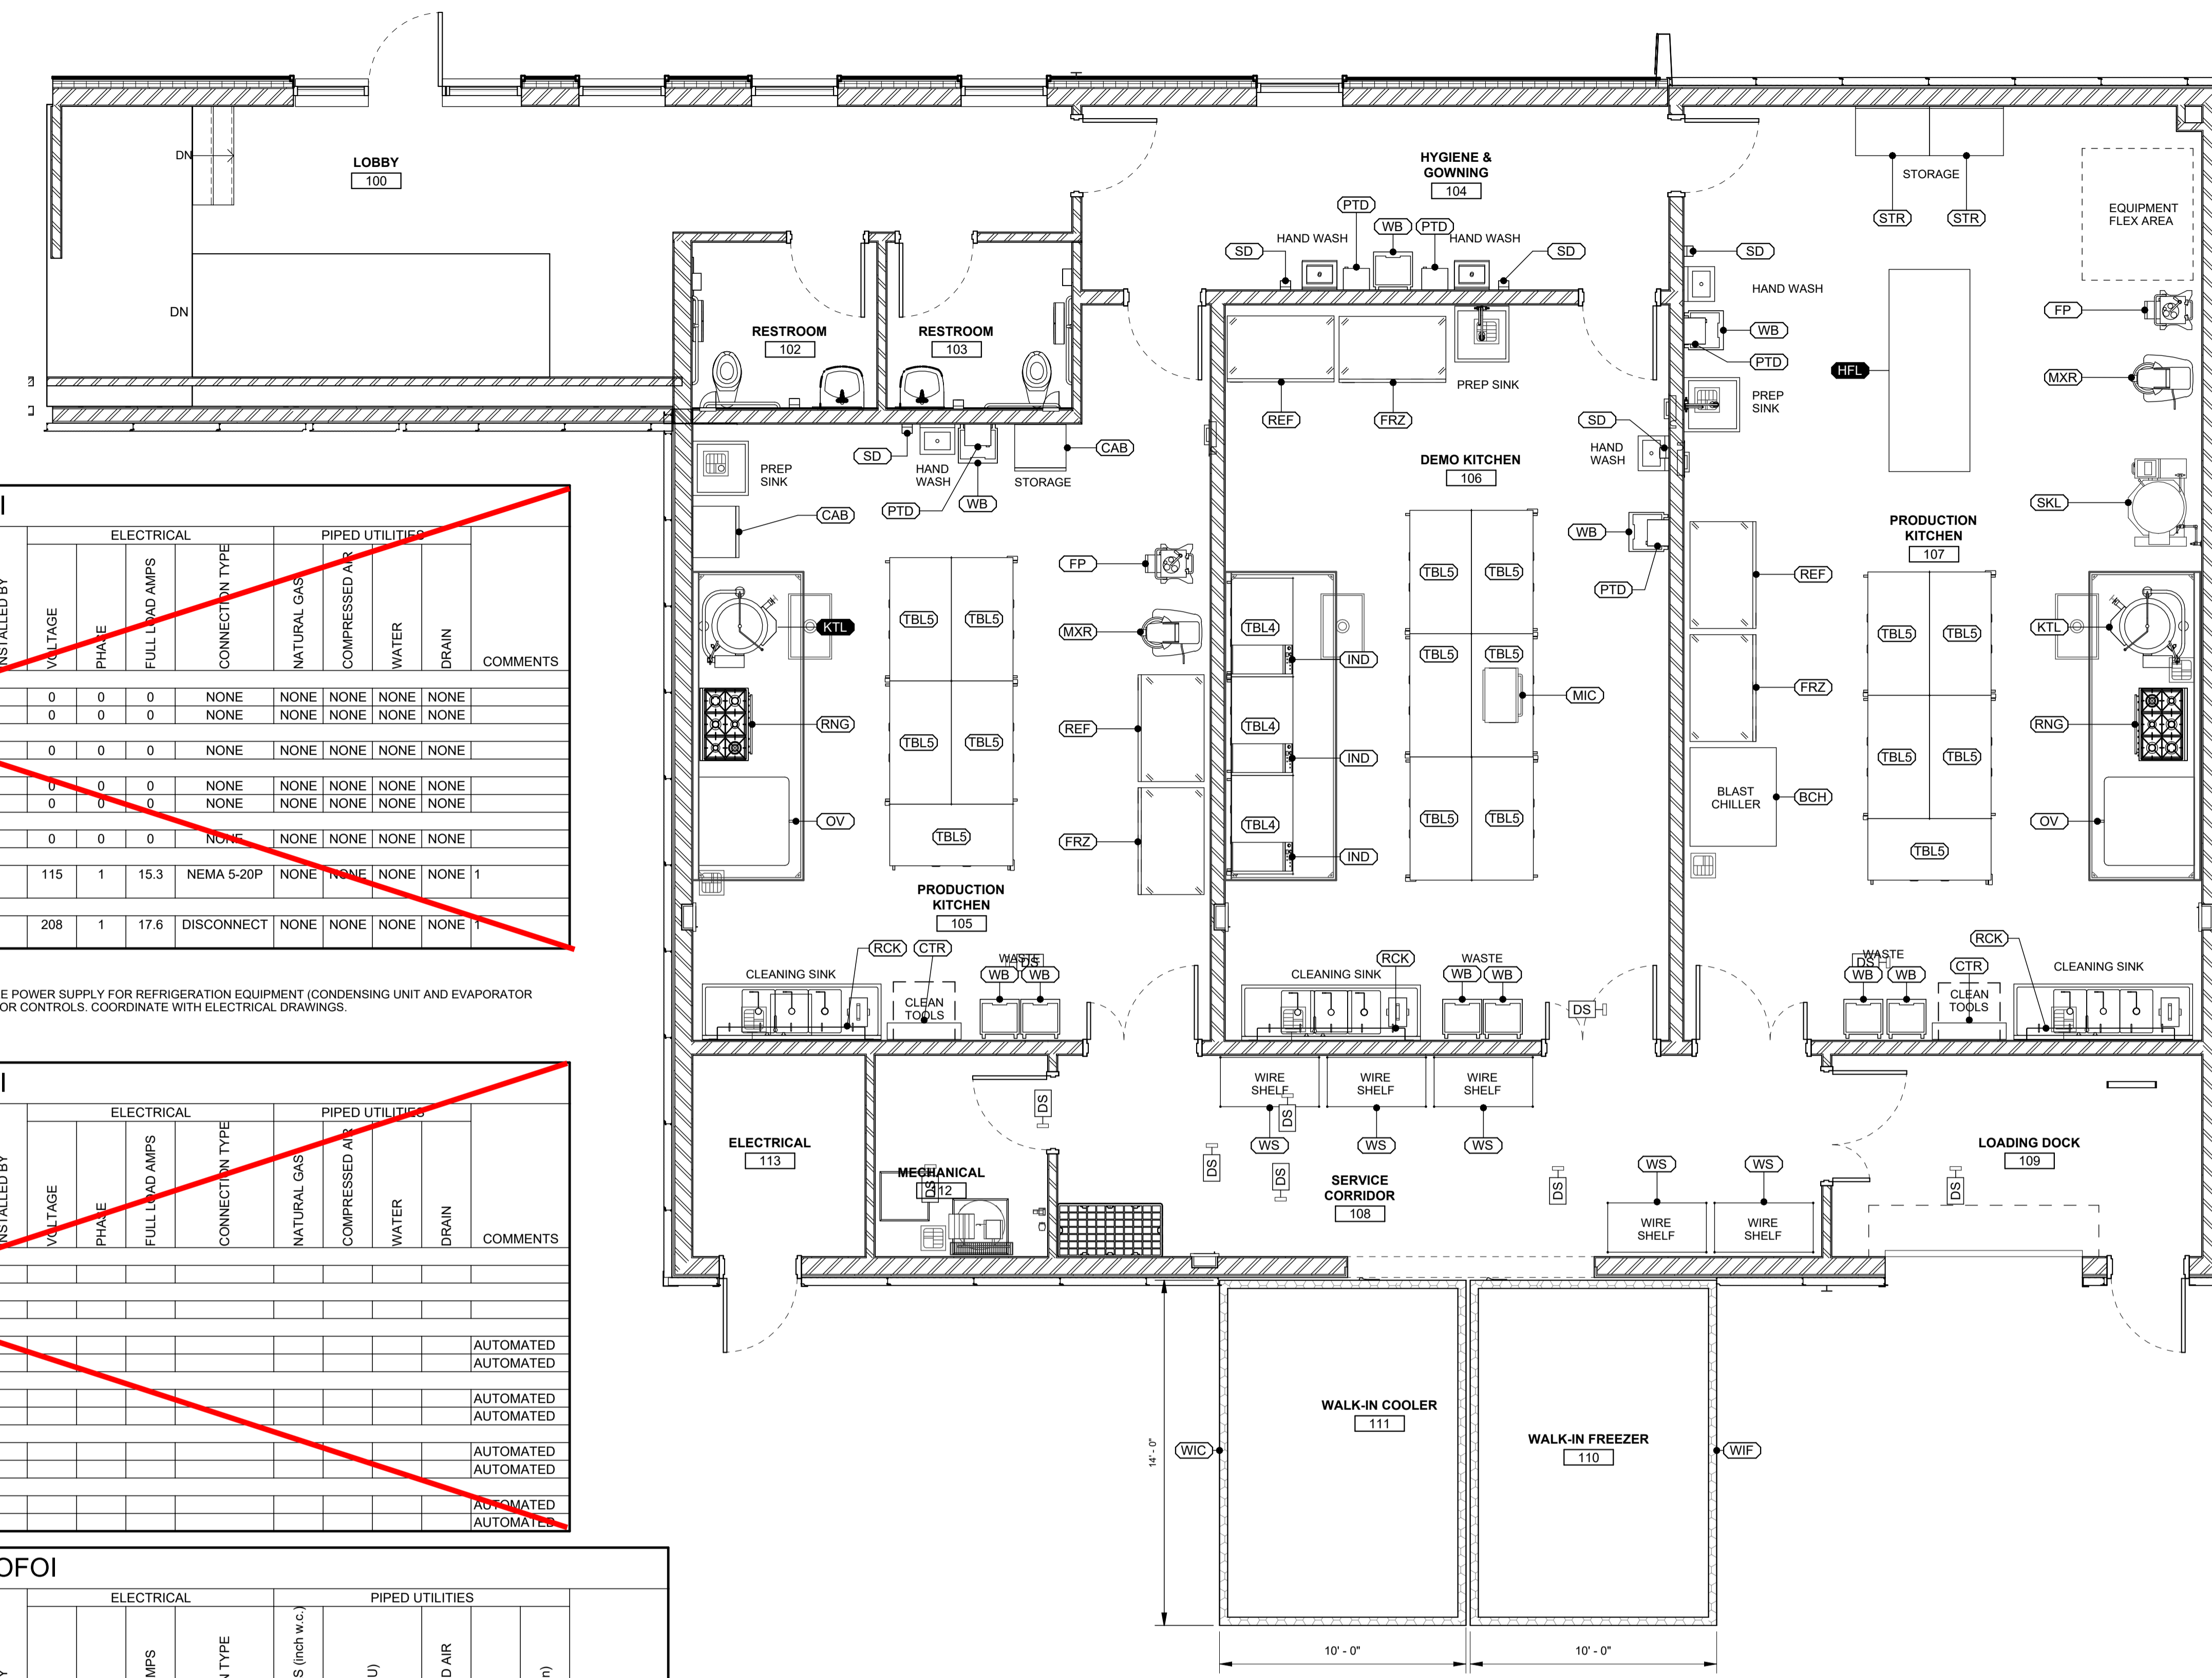

A2 FIRST FLOOR PLAN - FF&E
SCALE: 1/4" = 1'-0"

FF&E SCHEDULE - CFCI

ROOM NUMBER	TAG	COMMON NAME	MANUFACTURER	MODEL	COUNT	FURNISHED BY	INSTALLED BY	VOLTAGE	PHASE	FULL LOAD AMPS	CONNECTION TYPE	NATURAL GAS (inch w.c.)	COMPRESSED AIR	WATER (gpm)	DRAIN (gpm/min)	COMMENTS
105	CTR	RACK, CLEANING TOOLS	ADVANCE TABCO	K-246	1	CF/CI		0	0	0	NONE	NONE	NONE	NONE	NONE	
105	RCK	RACK, POT	AREO MFG	SBGPR-72	1	CF/CI		0	0	0	NONE	NONE	NONE	NONE	NONE	
106	RCK	RACK, POT	AREO MFG	SBGPR-72	1	CF/CI		0	0	0	NONE	NONE	NONE	NONE	NONE	
107	CTR	RACK, CLEANING TOOLS	ADVANCE TABCO	K-246	1	CF/CI		0	0	0	NONE	NONE	NONE	NONE	NONE	
107	RCK	RACK, POT	AREO MFG	SBGPR-72	1	CF/CI		0	0	0	NONE	NONE	NONE	NONE	NONE	
108	WS	RACK, WIRE, 24X48	QUANTUM	2448GY	5	CF/CI		0	0	0	NONE	NONE	NONE	NONE	NONE	
110	WIF	WALK-IN FREEZER W. FLOOR, OUTDOOR	NORLAKE	FAST TRACK 10X14, CPF100PC-E-0	1	CF/CI		115	1	15.3	NEMA 5-20P	NONE	NONE	NONE	NONE	1
111	WIC	WALK-IN COOLER W. FLOOR, OUTDOOR	NORLAKE	FAST TRACK 10X14, CPF200JC-R-4-EV	1	CF/CI		208	1	17.6	DISCONNECT	NONE	NONE	NONE	NONE	1

COMMENTS:
1) ENVIRONMENTAL CHAMBERS (WALK-IN UNITS) POWER CONNECTIONS TO BE COORDINATED WITH SELECTED VENDOR. BASIS OF DESIGN IS SINGLE POWER SUPPLY FOR REFRIGERATION EQUIPMENT (CONDENSING UNIT AND EVAPORATOR SECTIONS), SINGLE POWER SUPPLY FOR LIGHTING, SINGLE POWER SUPPLY FOR INTERNAL CONVENIENCE RECEPTACLE, SINGLE POWER SUPPLY FOR CONTROLS. COORDINATE WITH ELECTRICAL DRAWINGS.

FF&E SCHEDULE - OFCI



ROOM NUMBER	TAG	COMMON NAME	MANUFACTURER	MODEL	COUNT	FURNISHED BY	INSTALLED BY	VOLTAGE	PHASE	FULL LOAD AMPS	CONNECTION TYPE	NATURAL GAS (inch w.c.)	COMPRESSED AIR	WATER (gpm)	DRAIN (gpm/min)	COMMENTS
102	SD	SOAP DISPENSER	TBD	TBD	1	OF/CI										
103	SD	SOAP DISPENSER	TBD	TBD	1	OF/CI										
104	PTD	PAPER TOWEL DISPENSER	TBD	TBD	2	OF/CI										AUTOMATED
104	SD	SOAP DISPENSER	TBD	TBD	2	OF/CI										AUTOMATED
105	PTD	PAPER TOWEL DISPENSER	TBD	TBD	1	OF/CI										AUTOMATED
105	SD	SOAP DISPENSER	TBD	TBD	1	OF/CI										AUTOMATED
106	PTD	PAPER TOWEL DISPENSER	TBD	TBD	1	OF/CI										AUTOMATED
106	SD	SOAP DISPENSER	TBD	TBD	1	OF/CI										AUTOMATED
107	PTD	PAPER TOWEL DISPENSER	TBD	TBD	1	OF/CI										AUTOMATED
107	SD	SOAP DISPENSER	TBD	TBD	1	OF/CI										AUTOMATED

FF&E SCHEDULE - OFOI

ROOM NUMBER	TAG	COMMON NAME	MANUFACTURER	MODEL	COUNT	FURNISHED BY	INSTALLED BY	VOLTAGE	PHASE	FULL LOAD AMPS	CONNECTION TYPE	NATURAL GAS (inch w.c.)	COMPRESSED AIR	WATER (gpm)	DRAIN (gpm/min)	COMMENTS
105	OV	COMBI OVEN	RATIONAL	ICP 20 FULL NG	1	OF/OI		480	3	81.7	DISCONNECT	6.5-10	303,500	NONE	14.58	3.17
105	FP	FOOD PROCESSOR	ROBOT COUPE	R237	1	OF/OI		208	3	12.42	NEMA L15-30P	NONE	0	NONE	NONE	NONE
105	FRZ	FREEZER, 2 DOOR	ARTIC AIR	AF49	1	OF/OI		120	1	12	NEMA 5-15P	NONE	0	NONE	NONE	NONE
105	MXR	MIXER, FLOOR, 40QT	EURODIB USA	M40A 220ETL	1	OF/OI		208	3	5	DISCONNECT	NONE	0	NONE	NONE	NONE
105	RNG	RANGE & OVEN, GAS	ATOSA USA, INC	AGR-6B-NG	1	OF/OI		0	0	0	NA	4-5	219,000	NONE	NONE	NONE
105	REF	REFRIGERATOR, 2 DOOR	ARTIC AIR	AR49	1	OF/OI		120	1	4.5	NEMA 5-15P	NONE	0	NONE	NONE	NONE
105	TBL5	TABLE, 5FT MOBILE, SS	BK RESOURCES	VTT-6030	5	OF/OI		0	0	0	NA	NONE	0	NONE	NONE	NONE
105	WB	WASTE BIN	TBD	TBD	3	OF/OI		0	0	0	NA	NONE	0	NONE	NONE	NONE
106	FRZ	FREEZER, 2 DOOR	ARTIC AIR	AF49	1	OF/OI		120	1	12	NEMA 5-15P	NONE	0	NONE	NONE	NONE
106	IND	INDUCTION COOKTOP	HATCO	IRNG-PC2F-24-IA	3	OF/OI		208	1	8.66	NEMA 6-20P	NONE	0	NONE	NONE	NONE
106	MIC	MICROWAVE	SHARP	R-21LCFS	1	OF/OI		120	1	14	NEMA 5-15P	NONE	0	NONE	NONE	NONE
106	REF	REFRIGERATOR, 2 DOOR	ARTIC AIR	AR49	1	OF/OI		120	1	4.5	NEMA 5-15P	NONE	0	NONE	NONE	NONE
106	TBL4	TABLE, 4FT MOBILE, SS	BK RESOURCES	VTT-4830	3	OF/OI		0	0	0	NONE	NONE	0	NONE	NONE	NONE
106	TBL5	TABLE, 5FT MOBILE, SS	BK RESOURCES	VTT-6030	6	OF/OI		0	0	0	NA	NONE	0	NONE	NONE	NONE
106	WB	WASTE BIN	TBD	TBD	3	OF/OI		0	0	0	NA	NONE	0	NONE	NONE	NONE
107	BCH	BLAST CHILLER	AMERICAN PANEL	AP20BCF200-3	1	OF/OI		208	3	19.5	DISCONNECT	NONE	NONE	NONE	NONE	NONE
107	OV	COMBI OVEN	RATIONAL	ICP 20 FULL NG	1	OF/OI		480	3	81.7	DISCONNECT	6.5-10	303,500	NONE	14.58	3.17
107	FP	FOOD PROCESSOR	ROBOT COUPE	R237	1	OF/OI		208	3	12.42	NEMA L15-30P	NONE	0	NONE	NONE	NONE
107	FRZ	FREEZER, 2 DOOR	ARTIC AIR	AF49	1	OF/OI		120	1	12	NEMA 5-15P	NONE	0	NONE	NONE	NONE
107	KTL	KETTLE, ELECTRIC, 40 GAL	GROEN	TDBC-40C	1	OF/OI		208	3	30	DISCONNECT	NONE	0	NONE	NONE	NONE
107	MXR	MIXER, FLOOR, 40QT	EURODIB USA	M40A 220ETL	1	OF/OI		208	3	5	DISCONNECT	NONE	0	NONE	NONE	NONE
107	RNG	RANGE & OVEN, GAS	ATOSA USA, INC	AGR-6B-NG	1	OF/OI		0	0	0	NA	4-5	219,000	NONE	NONE	NONE
107	REF	REFRIGERATOR, 2 DOOR	ARTIC AIR	AR49	1	OF/OI		120	1	4.5	NEMA 5-15P	NONE	0	NONE	NONE	NONE
107	STR	STORAGE CABINET	ADVANCE TABCO	HK-SS-243	2	OF/OI		0	0	0	NA	NONE	0	NONE	NONE	NONE
107	TBL5	TABLE, 5FT MOBILE, SS	BK RESOURCES	VTT-6030	5	OF/OI		0	0	0	NA	NONE	0	NONE	NONE	NONE
107	SKL	TILTING SKILLET, ELECTRIC, 18GAL	FIREX	UCBTE018V1	1	OF/OI		208	3	24.5	DISCONNECT	NONE	0	NONE	40	8
107	WB	WASTE BIN	TBD	TBD	3	OF/OI		0	0	0	NA	NONE	0	NONE	NONE	NONE

FF&E SCHEDULE - OUT OF SCOPE - FUTURE

ROOM NUMBER	TAG	COMMON NAME	MANUFACTURER	MODEL	COUNT	FURNISHED BY	INSTALLED BY	VOLTAGE	PHASE	FULL LOAD AMPS	CONNECTION TYPE	NATURAL GAS (inch w.c.)	COMPRESSED AIR	WATER (gpm)	DRAIN (gpm/min)	COMMENTS
105	KTL	KETTLE, ELECTRIC, 40 GAL	GROEN	TDBC-40C	1	OF/OI		208	3	30	DISCONNECT	NONE	NONE	40	8	
107	HFL	HOT FILL LINE	APEX FILLING SYSTEMS	TABLETOP PISTON FILLER	1	OF/OI		0	0	0	NA	NONE	2-4	NONE	NONE	

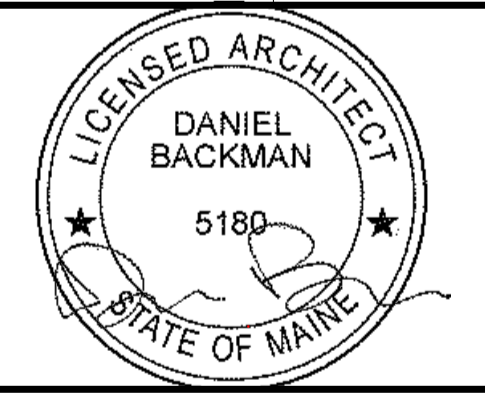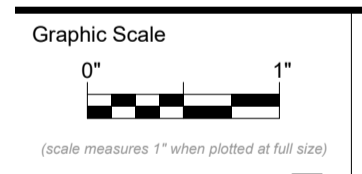

CONFORMANCE SET

JANUARY 12, 2026

Revision Date	Revision Description

Drawn by: JWA